


\\s14.047\...100-base.dwg

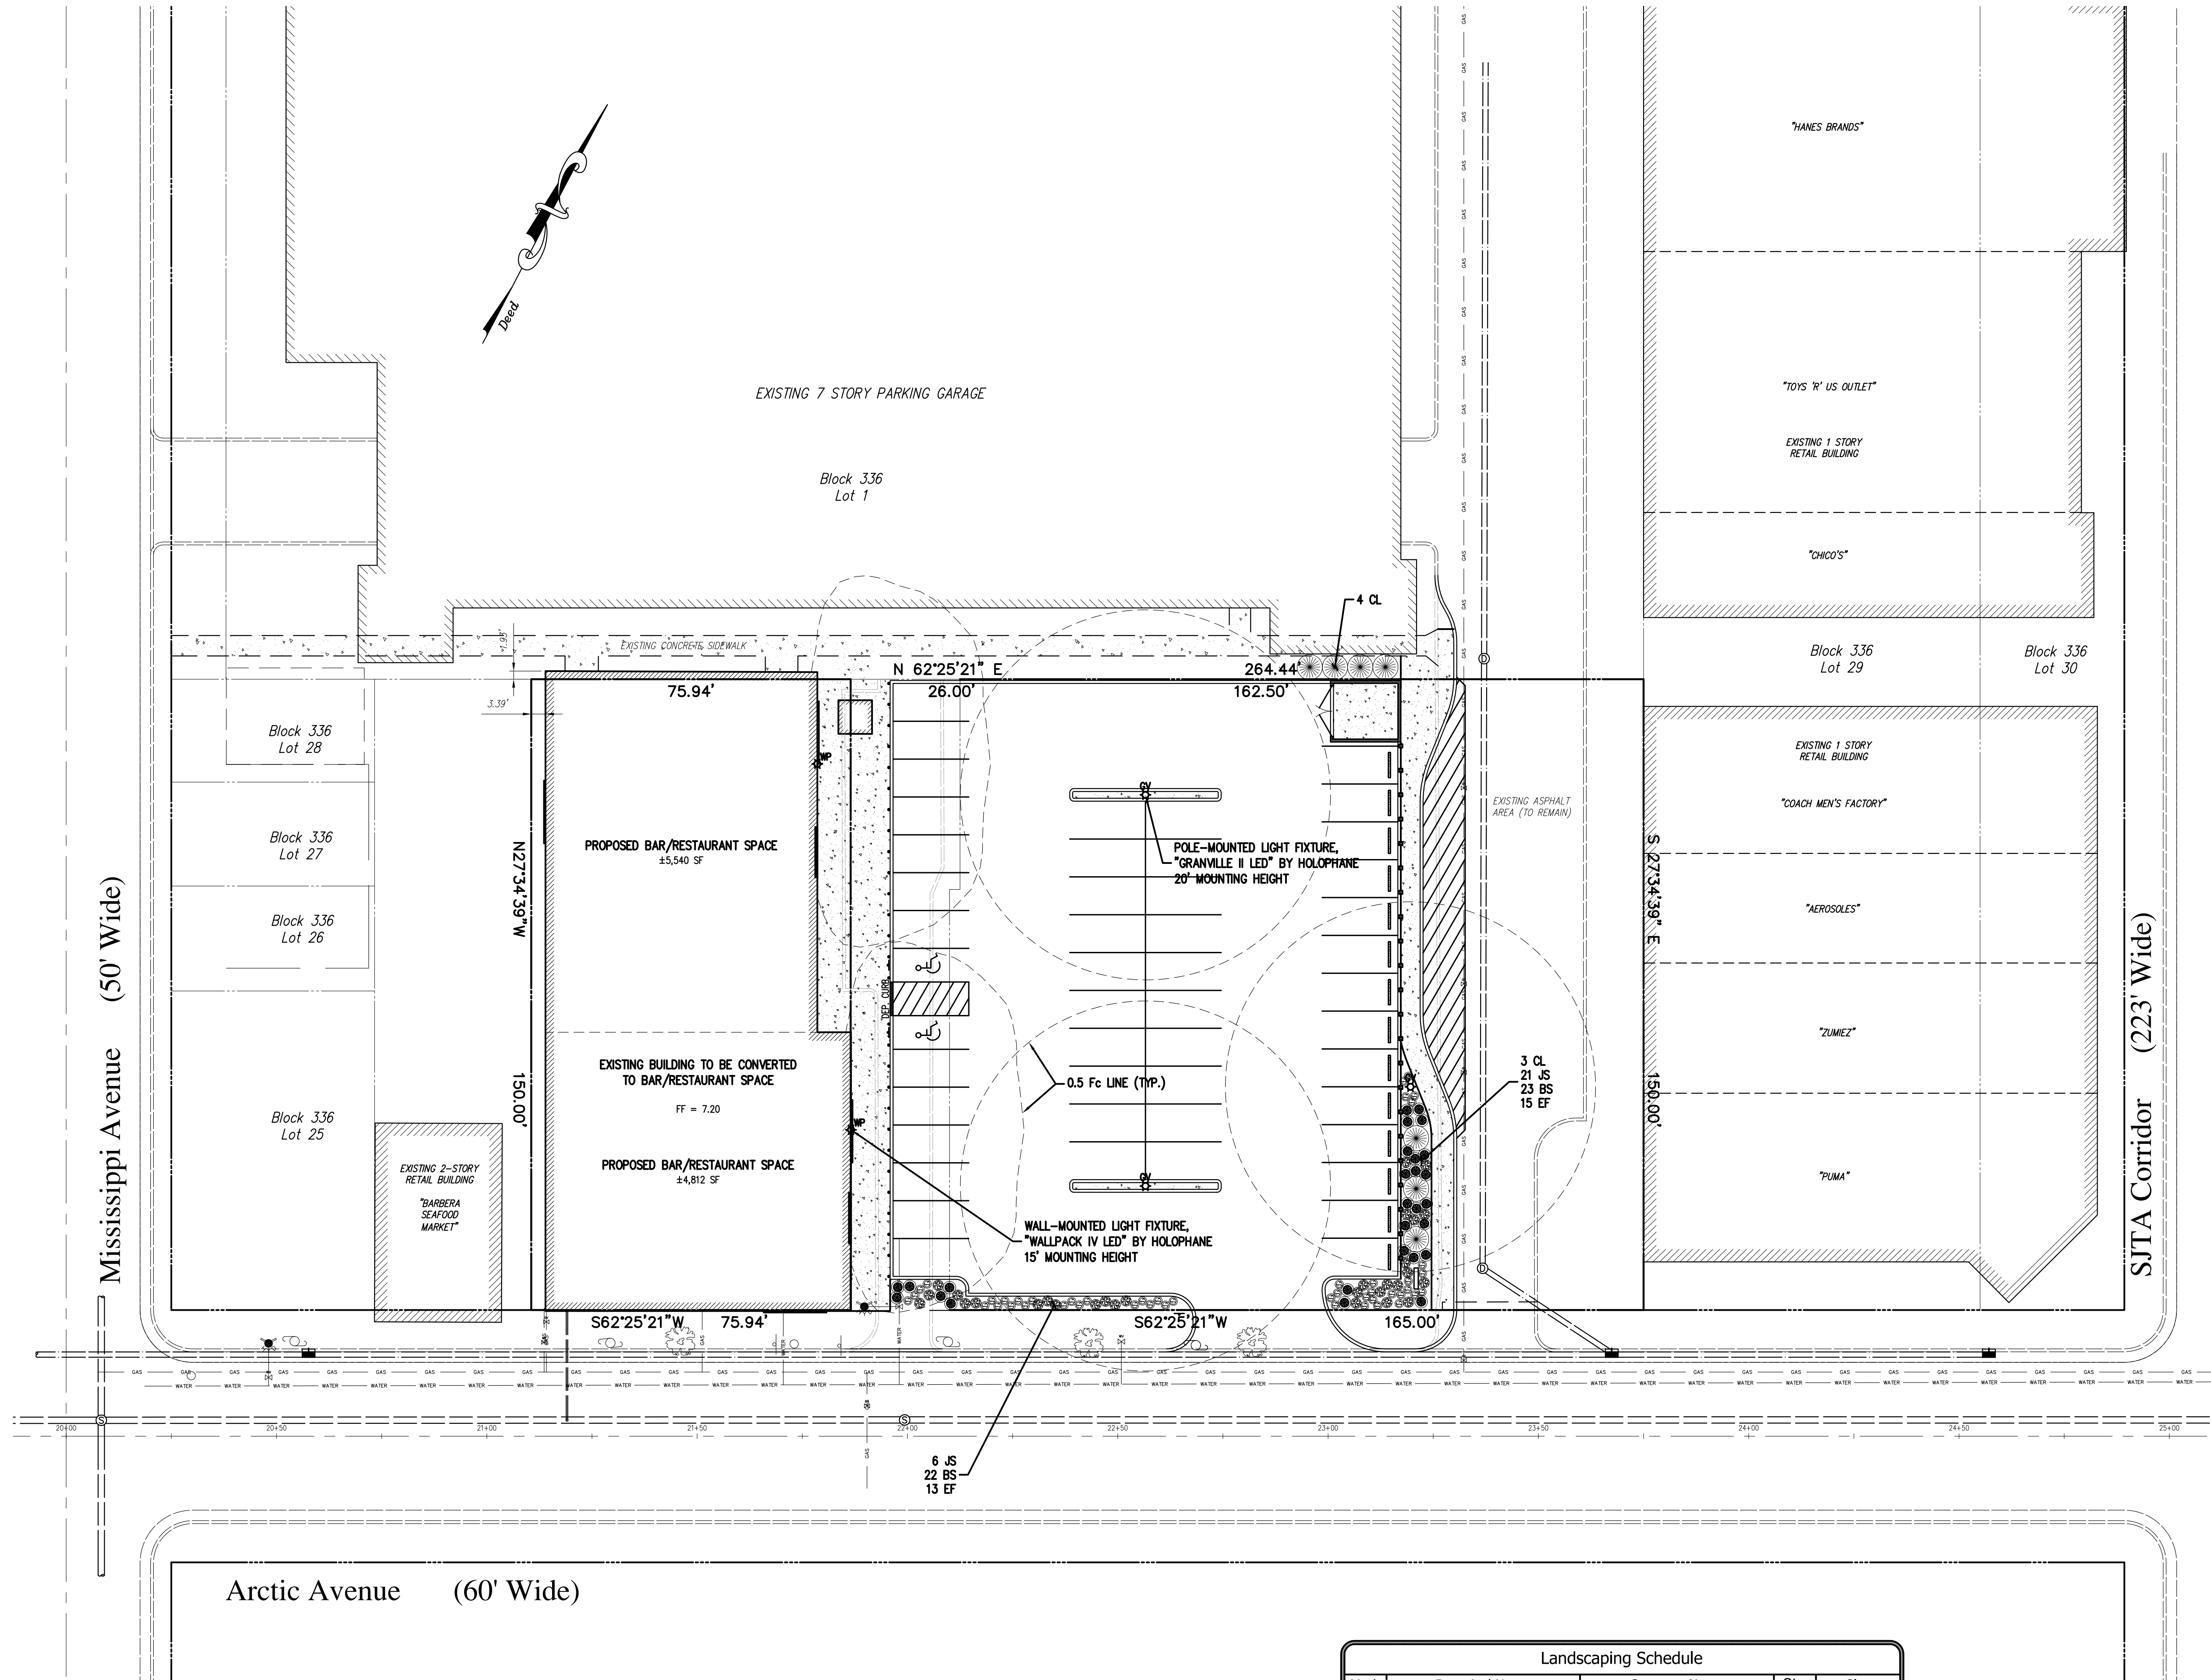


Arctic Avenue (60' Wide)

Mississippi Avenue (50' Wide)

SJTA Corridor (223' Wide)

Landscaping Schedule				
Mark	Botanical Name	Common Name	Qty.	Size
CL	Cupressus leylandi	Leyland Cypress	7	4"
BS	Buxus sempervirens	Common Boxwood	45	12" - 18"
JS	Juniperus squamata	Blue Star Juniper	27	4" - 8"
EF	Euonymus fortunei	Moon Shadow Winter Creeper	28	6" - 1"

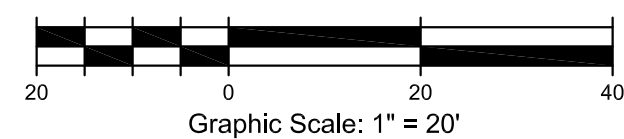

Endicott Engineering
 319 E. Jimmie Leeds Road, Suite 701
 Galloway, NJ 08205
 Phone (609) 652-8350 Fax (609) 652-8359
 e-mail: office@endicottengineering.com
 www.endicottengineering.com

JTD Realty Group, Inc.
 Block 336, Lots 2-23 - 2231 Arctic Avenue
 Landscaping & Lighting Plan

City of Atlantic City, Atlantic County, New Jersey
 Application for Preliminary & Final Major Site Plan Approval for

Scale: As Noted
 Date: 03-24-15

Designed: CEE
 Drawn: STAFF
 Checked: CEE
 Approved: CEE

Charles E. Endicott
 Professional Engineer
 New Jersey License No. 41933

Professional Engineer and Land Surveyor's Certificate of Authorization
 Endicott Engineering, LLC
 assumes full liability for the accuracy of this drawing for anyone other than the person(s) who originally contacted the work.

Date: _____
 Revision: _____

6

Sheet No.

10

Total Sheets