

# PROJECT DATA:

PROJECT NAME: HRAC - Service Station

Pacific & Virginia Ave.  
Atlantic City, NJ 08401


SOSH PROJECT No.: 17013.03

DEVELOPER: Hard Rock International

LIST OF DRAWINGS - ARCHITECTURAL (CAFRA & NJCRDA)	
SHEET NUMBER	SHEET NAME
A-25-000	COVER SHEET
A-25-201	FLOOR PLAN
A-25-202	ROOF PLAN
A-25-301	ELEVATIONS
A-25-401	BUILDING SECTIONS

LIST OF DRAWINGS - CIVIL (CAFRA & NJCRDA)	
SHEET NUMBER	SHEET NAME
C-25-000	TITLE SHEET
C-25-001	PROPERTY SURVEY
C-25-002	SITE DEVELOPMENT PLAN
C-25-003	GRADING, DRAINAGE & UTILITY
C-25-004	SOIL EROSION & SED. CONTROL PLAN
C-25-005	SITE DETAILS
C-25-006	SITE DETAILS

LIST OF DRAWINGS - LANDSCAPING (CAFRA & NJCRDA)	
SHEET NUMBER	SHEET NAME
L-25-000	OVERALL ILLUSTRATIVE PLAN
L-25-001	SHEET INDEX
L-25-100	DEMOLITION NOTES
L-25-101	DEMOLITION PLAN
L-25-110	PLANTING NOTES AND SCHEDULE
L-25-111	PLANTING PLAN
L-25-120	LIGHTING NOTES AND SCHEDULE
L-25-121	LIGHTING PLAN
L-25-510	LANDSCAPE DETAILS
L-25-520	LIGHTING DETAILS
L-25-521	LIGHTING DETAILS

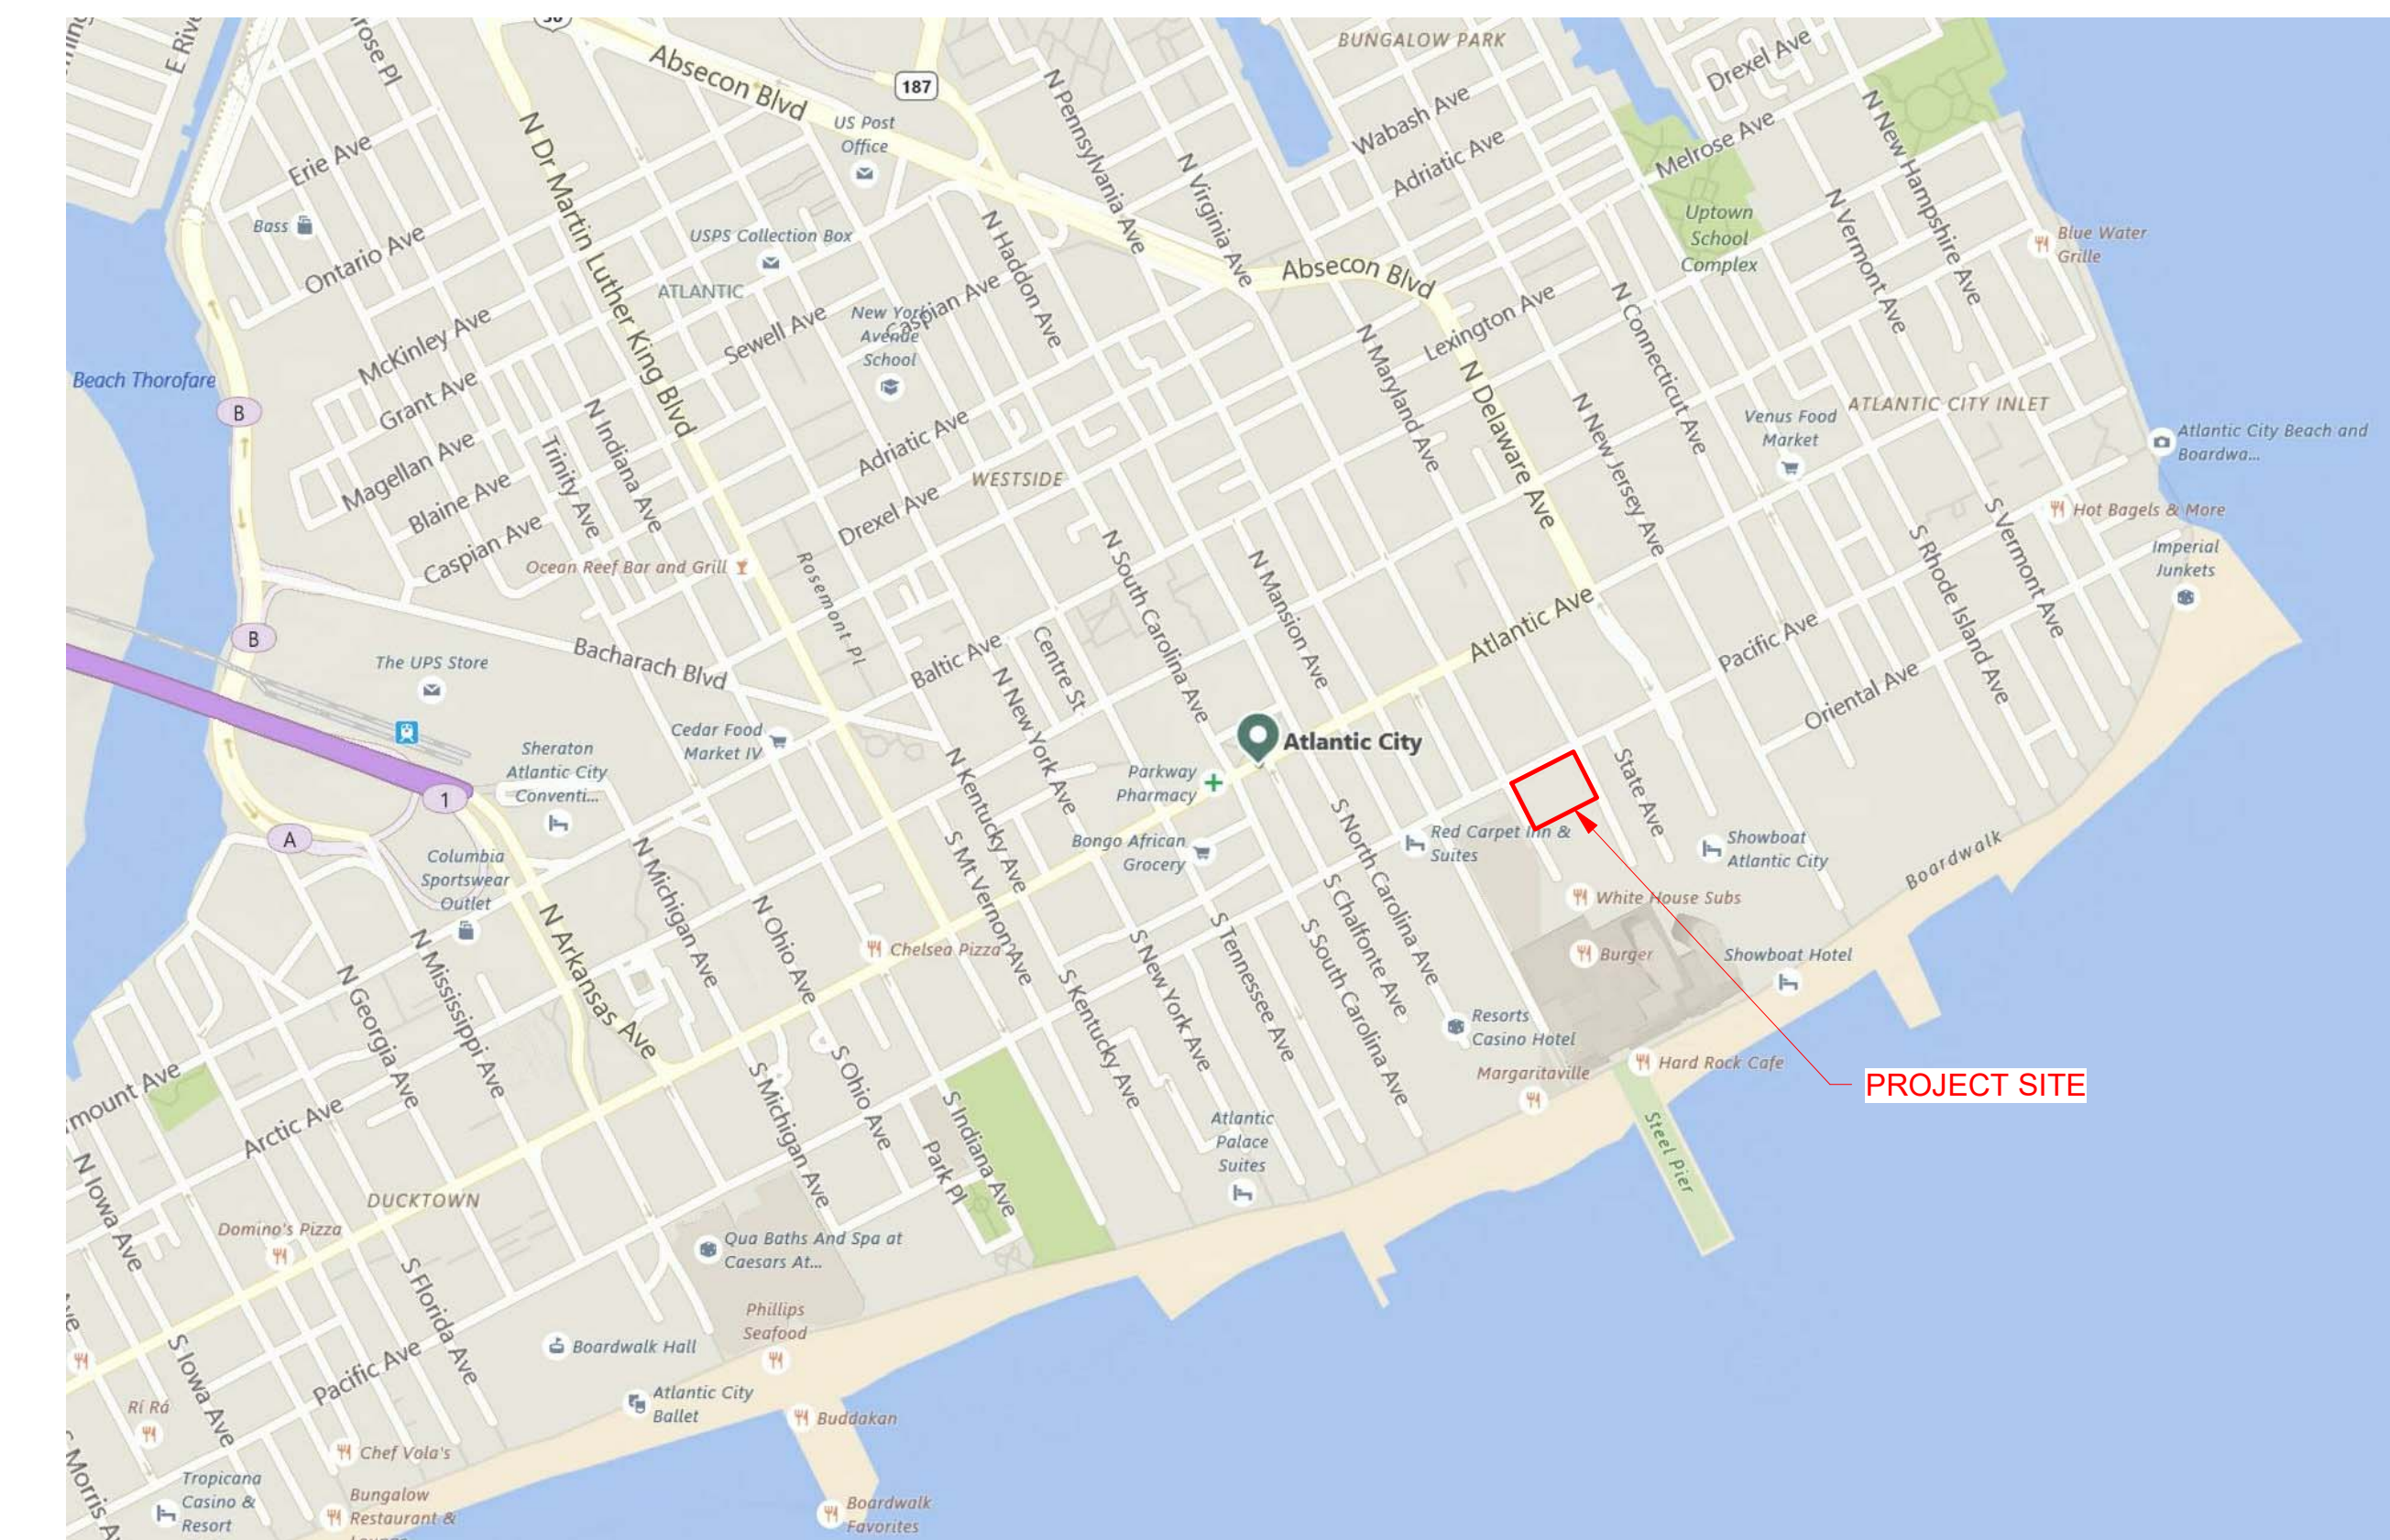

Architect of Record:

**SOSH**  
1020 Atlantic Ave.  
Atlantic City, NJ 08401  
t: 609 - 345 - 5222  
f: 609 - 345 - 7486  
www.sosharch.com

Owner / Operator:

**HARD ROCK INTERNATIONAL**  
6100 Old Park Lane  
Orlando, FL 32835  
t: 407 - 445 - 7999  
www.hardrock.com  
att: Joe Emanuele, Sr. V.P.

Project Management:

**HARD ROCK ATLANTIC CITY ONSITE PROJECT MANAGEMENT TEAM**  
1000 Boardwalk  
Atlantic City, NJ 08401  
att: Joe Polisano

Civil:

**A.W. PONZIO ASSOCIATES**  
400 N. Dover Avenue  
Atlantic City, NJ 08401  
t: 609 - 344 - 8194  
f: 609 - 344 - 1594  
www.awponzio.com  
att: Jon Barnhart,  
Principal

MPE:

**GSA ENGINEERS**  
370 Reed Road  
Suite 201  
Broomall, PA 19008  
t: 610 - 328 - 7700  
www.g-sa.com  
att: Joe Ruffo, Sr. V.P.

CAFRA/Planning:

**JEROME ASSOCIATES**  
426 South Shore Road  
Absecon, NJ 08201  
t: 609 - 646 - 6300  
f: 609 - 646 - 1669  
att: Ian P. Jerome PPI/AICP,  
Principal

Environmental:

**WESTON SOLUTIONS**  
1400 Weston Way  
West Chester, PA 19380  
t: 610 - 701 - 3000  
f: 610 - 701 - 3186  
att: Joe Dempsey

Structural:

**O'DONNELL & NACCARATO**  
701 Market Street  
Suite 6000  
Philadelphia, PA 19106  
t: 215 - 717 - 3679  
f: 215 - 627 - 1051  
www.o-n.com  
att: Mike Miller, P.E.

Landscaping:

**EDSA**  
Inner Harbor Center  
400 East Pratt Street  
Suite 902  
Baltimore, MD 21202  
t: 443 - 539 - 3350  
www.edsaplan.com  
att: Rich Centolella,  
Principal

Building Envelope:

**EDWARDS AND COMPANY**  
1022 Keystone Drive  
Sellersville, PA 18960  
t: 215 - 703 - 0628  
att: Bob Edwards,  
Principal

Food Service:

**Corsi & Associates, NJ**  
6712 Washington Ave  
Suite 209A  
Egg Harbor Twp., NJ 08234  
t: 609 - 204 - 0205  
att: Jon S. Rosky, VP

Security / CCTV:

**M. MALIA & ASSOCIATES**  
6712 Washington Avenue  
Suite 111  
Egg Harbor Twp., NJ 08234  
t: 609 - 645 - 5030  
f: 609 - 645 - 5031  
www.mmalia.com  
att: Mike Malia, Principal

Contractor

**JOSEPH JINGOLI & SONS**  
100 Lenox Drive  
Suite 100  
Lawrenceville, NJ 08648  
t: 609 - 512 - 2262  
www.jingoli.com  
att: Dennis Mockaitis, Sr. V.P.

Lighting:

**ChromaLD**  
2120 Belmead Ave.  
Suite 14-1  
Havertown, PA 19083  
t: 610 - 624 - 4140  
www.ChromaLD.com  
att: Troy Hornung



Audio/Visual:

**KMK TECHNOLOGIES, LLC**  
5 Covey Place  
Montroeville, NJ 08043  
t: 215 - 990 - 3187  
www.marshall-kmk.com  
att: Tom Krauss, CTS-D

## CAFRA & NJCRDA SUBMISSION - 2017 12 01

# HRAC - Service Station

Pacific & Virginia Ave.  
Atlantic City, NJ 08401

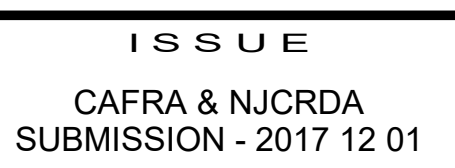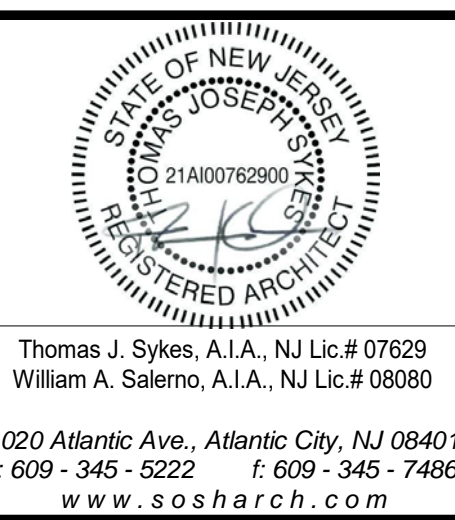

REVISIONS		
No.	Date	Description

DRAWING TITLE: COVER SHEET	
DRAWN BY: Author	
SCALE:	
DATE: 2017 12 01	
PROJECT NO.: 17013.03	
DRAWING NO. A-25-000	

SOSH ARCHITECTURE