

ATLANTIC AVENUE ROAD DIET - PHASE 2B

ALBANY AVENUE TO MAINE AVENUE

FEDERAL PROJECT NO. STBGP-1100 (302)

NJDOT JOB NO. 5502340




DATE: 5/20/2024
FRANK J. SENEY JR.
NJ PROFESSIONAL ENGINEER LIC. No. 35321

PRELIMINARY

PLANS WHICH DO NOT BEAR AN EMBOSSED SEAL ARE NOT VALID.
ALL DOCUMENTS PREPARED BY REMINGTON & VERNICK ENGINEERS AND AFFILIATES ARE INSTRUMENTS OF SERVICE IN RESPECT OF THE PROJECT. THEY ARE NOT INTENDED OR REPRESENTED TO BE SUITABLE FOR REUSE BY OWNER OR OTHERS ON EXTENSIONS OF THE PROJECT OR ON ANY OTHER PROJECT. ANY REUSE WITHOUT WRITTEN VERIFICATION OR ADAPTATION BY REMINGTON & VERNICK ENGINEERS AND AFFILIATES FOR THE SPECIFIC PURPOSE INTENDED WILL BE AT OWNERS SOLE RISK AND WITHOUT LIABILITY OR LEGAL EXPOSURE TO REMINGTON & VERNICK ENGINEERS AND AFFILIATES. OWNER SHALL INDEMNIFY AND HOLD HARMLESS REMINGTON & VERNICK ENGINEERS AND AFFILIATES FROM ALL CLAIMS, DAMAGES, LOSSES AND EXPENSES ARISING OUT OF OR RESULTING THEREFROM.

LIST OF UTILITIES AND EMERGENCY CONTACT INFORMATION	
FIRE DEPARTMENT:	ATLANTIC CITY FIRE DEPARTMENT 2715 ATLANTIC AVENUE ATLANTIC CITY, NJ 08401 609-347-5590
POLICE DEPARTMENT:	ATLANTIC CITY POLICE DEPARTMENT 2711 ATLANTIC AVENUE ATLANTIC CITY, NJ 08401 609-347-5779
WATER:	ATLANTIC CITY MUNICIPAL UTILITIES AUTHORITY 401 VIRGINIA AVENUE ATLANTIC CITY, NJ 08401 609-345-3315
SEWER:	ATLANTIC CITY SEWERAGE AUTHORITY 1200 ATLANTIC AVENUE, P.O. BOX 1830 ATLANTIC CITY, NJ 08404 609-345-0131
ELECTRIC:	ATLANTIC CITY ELECTRIC 2542 FIRE ROAD EGG HARBOR TOWNSHIP, NJ 08234 609-645-4780
CABLE:	COMCAST CABLE 1846 NW BOULEVARD VINELAND, NJ 08360 800-934-6489
GAS:	SOUTH JERSEY INDUSTRIES 1 SOUTH JERSEY PLACE ATLANTIC CITY, NJ 08401 609-561-9000
TELEPHONE:	VERIZON NEW JERSEY, INC. 10 TANSBORO ROAD BERLIN, NJ 08009 856-306-8611

FUNDING SOURCE:
FHWA

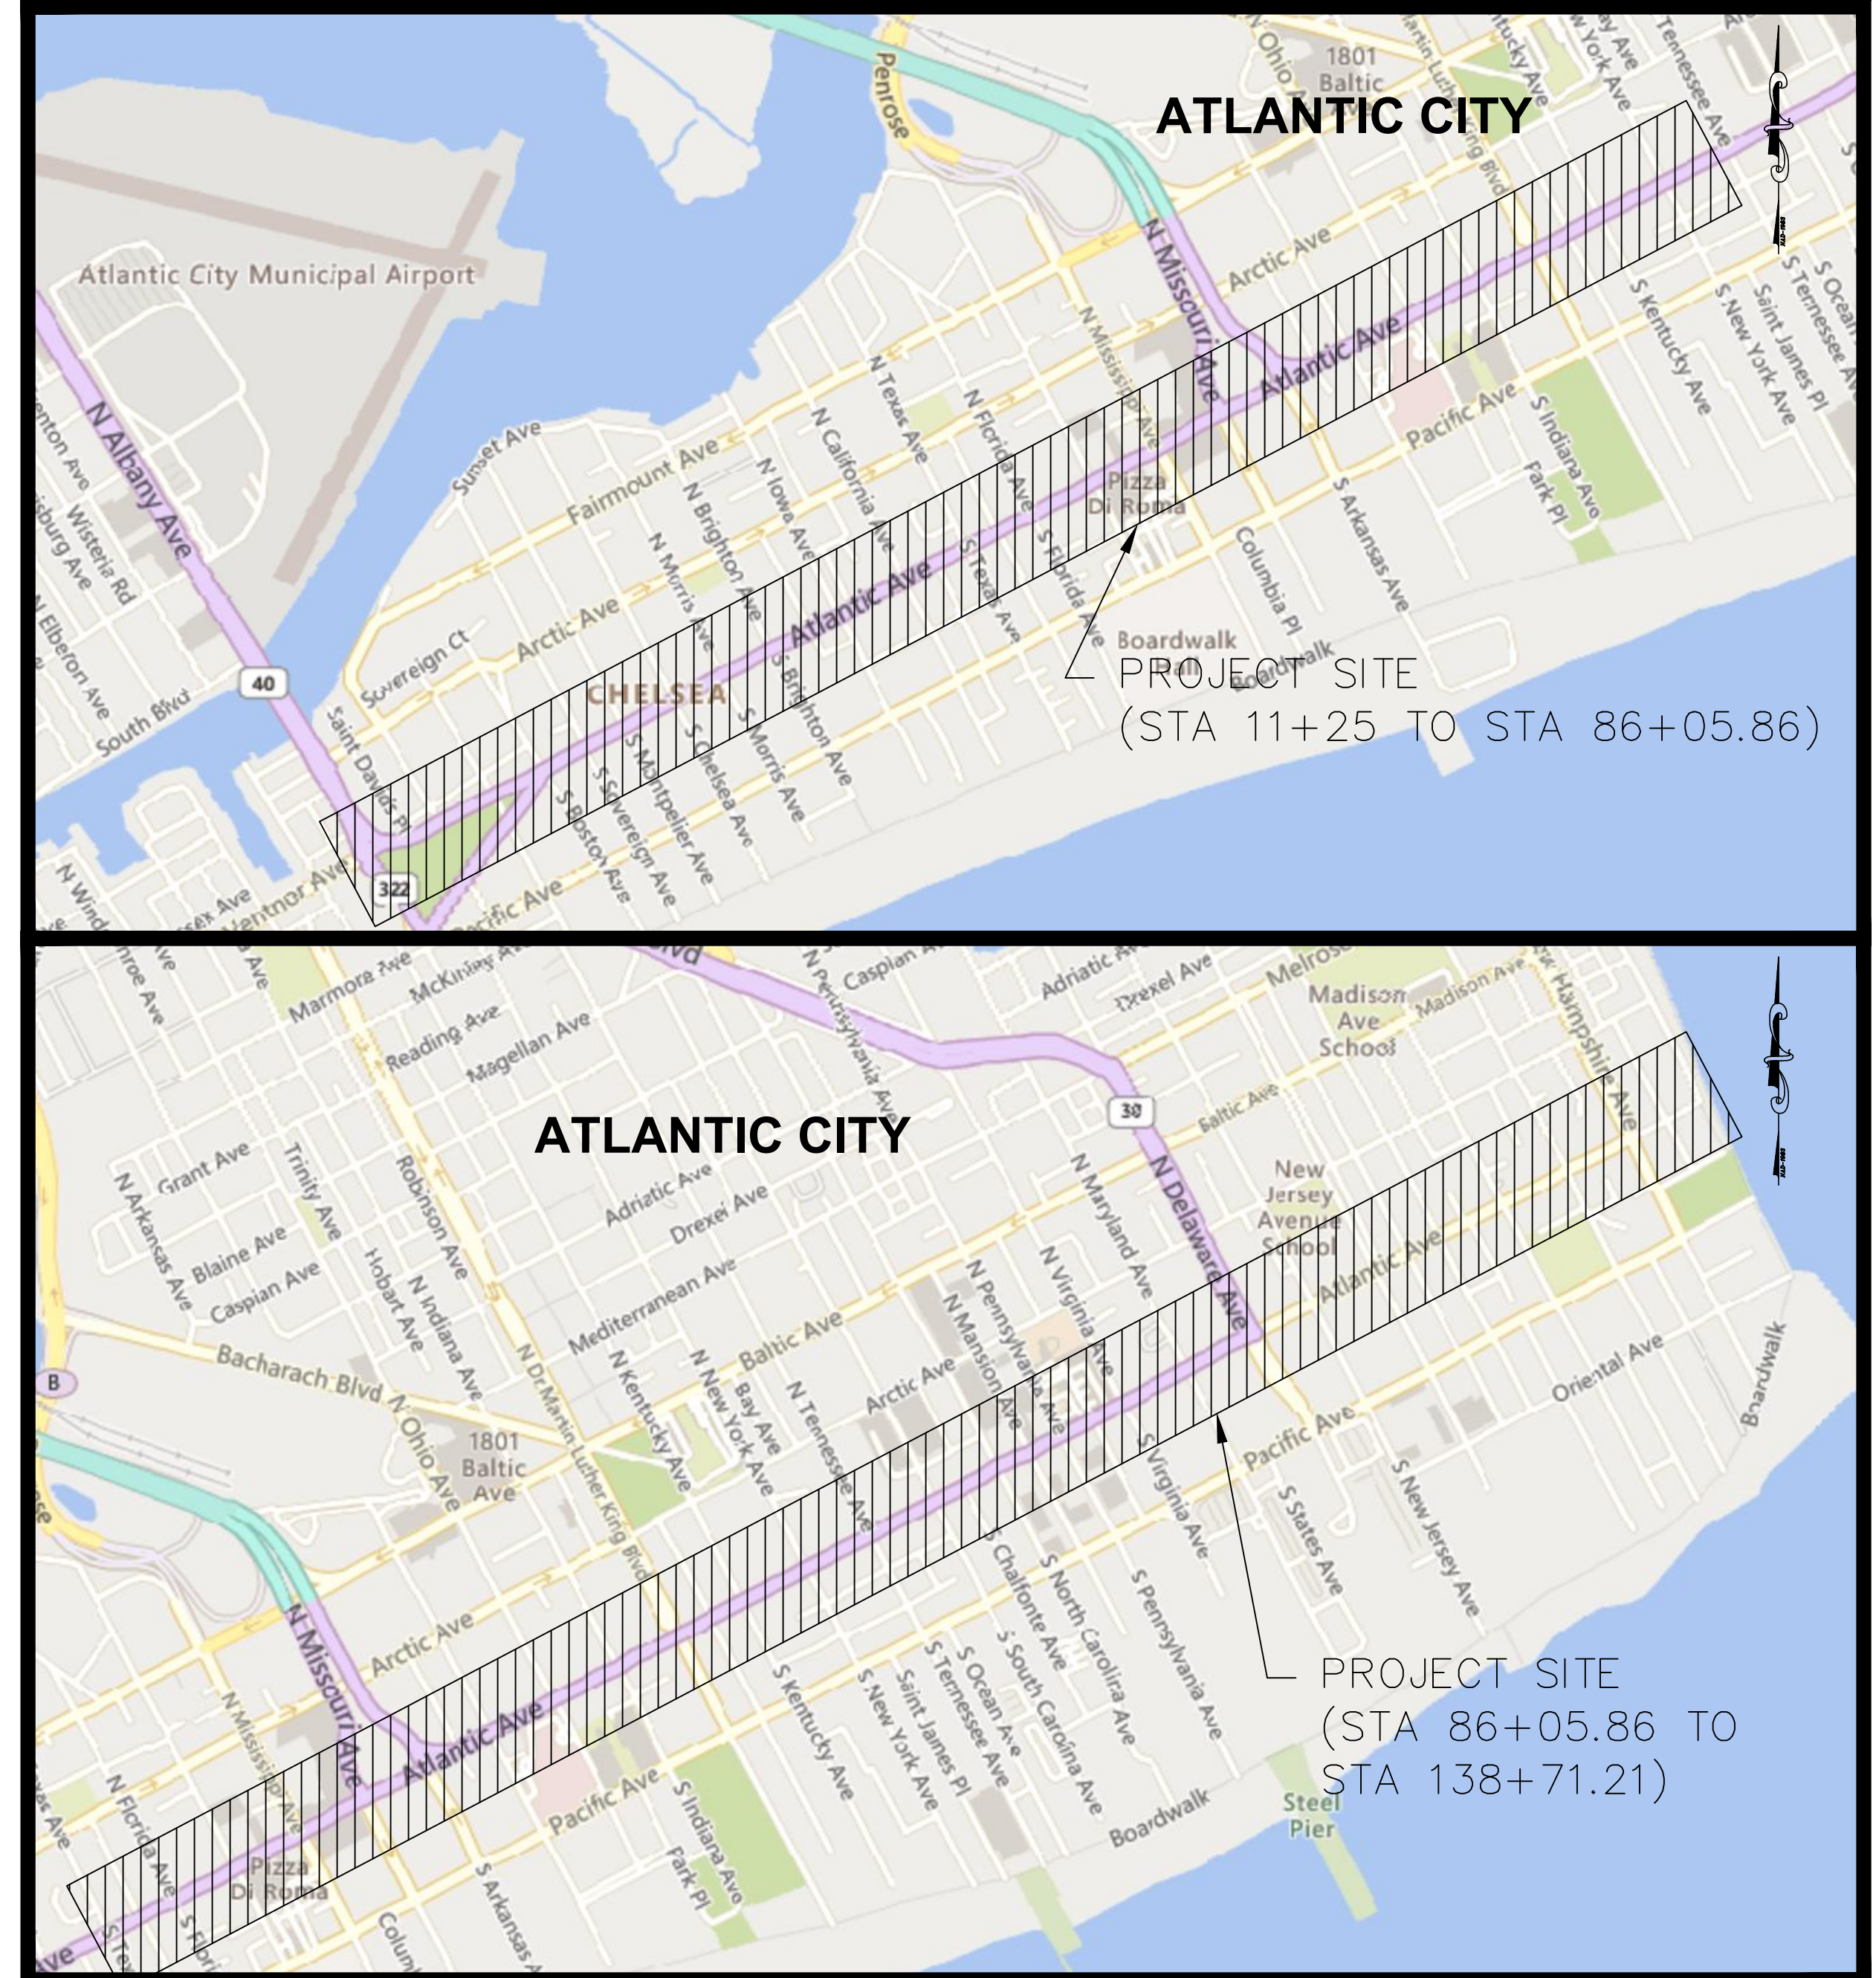

PROJECT LOCATION MAP

CITY OF ATLANTIC CITY

ATLANTIC COUNTY, NEW JERSEY

MAY, 2024

SHEET INDEX	
SHEET #	DESCRIPTION
1	TITLE SHEET
2	LEGEND
3	ESTIMATE & DISTRIBUTION OF QUANTITIES
4	GENERAL NOTES
5	TYPICAL SECTION
6-11A	CONSTRUCTION PLAN
12-22	LIGHTING PLAN
23	TRAFFIC SIGNALIZATION PLAN
24-25	ELECTRICAL PLAN
26-31	SIGNAGE AND STRIPING PLAN
32-41	CURB RAMP DETAILS
42-45	CONSTRUCTION DETAILS
46	TRAFFIC CONTROL DETAILS

NOTES:

THE ELECTRONIC VERSION OF THE 2019 NEW JERSEY DEPARTMENT OF TRANSPORTATION STANDARD SPECIFICATIONS FOR ROAD AND BRIDGE CONSTRUCTION, EFFECTIVE SEPTEMBER 1, 2019, AS REFERENCED IN BASELINE DOCUMENT CHANGE ANNOUNCEMENT BDC19S-01, UNLESS MODIFIED WITHIN THE TECHNICAL SPECIFICATIONS OF THIS CONTRACT, SHALL GOVERN.

THE NEW JERSEY DEPARTMENT OF TRANSPORTATION "STANDARD ROADWAY CONSTRUCTION\TRAFFIC CONTROL\BRIDGE CONSTRUCTION DETAILS" BOOKLET DATED 2016 AND "ELECTRICAL BUREAU STANDARD DETAILS, 2007" AND ALL BASELINE DOCUMENT CHANGES MADE TO THESE CONSTRUCTION DETAILS, SHALL GOVERN, EXCEPT FOR THOSE DETAILS CONTAINED HEREIN.

New Jersey One Call
CALL BEFORE YOU DIG
811 or 1-800-272-1000
ITS THE LAW

IT IS THE RESPONSIBILITY OF THE CONTRACTOR TO CONTACT NJ ONE CALL PRIOR TO THE START OF CONSTRUCTION. CALL FOR MARKOUTS THREE (3) FULL BUSINESS DAYS IN ADVANCE AND BEGIN EXCAVATION WITHIN 10 DAYS. ALL CONTRACTORS ON-SITE MUST HAVE THEIR OWN MARKOUT.

NO.	REVISION	DATE	BY	CHK

TITLE SHEET
CITY OF ATLANTIC CITY
ATLANTIC AVENUE ROAD DIET - PHASE 2B
CITY OF ATLANTIC CITY
ATLANTIC COUNTY
NEW JERSEY

DRAWN BY:	DESIGN BY:	CHECKED BY:	SCALE:
C.F.C.	T.J.M.	D.K.	AS NOTED
DATE:	SHEET No.:		
8-3-2023	1 of 46		
JOB No.:	01-02-U-016		